


Proposed Additions 80 Byron Street Christchurch For Clip & Climb


Amendment #2


Architectural Index


Sheet	Issue	Drawing
A1	1	Site Plan Existing
A2	3	Site Plan Proposed
A4	6	Plumbing Plan
A5	2	Floor Plan Existing
A6	7	Floor Plan Proposed
A7	2	Framing Plan
A8	5	Elevations
A9	2	Foundation Plan
A10	1	Accessible Toilet
A11	3	Architectural Sections
A12	3	Gridline Cross Sections
A13	1	Architectural Details
A14	1	Architectural Details
A15	4	Architectural Details
A16	5	Joinery Details
A17	4	Steel Work Plan
A18	1	Gridline 1 Steel details
A19	2	Roof Plan
A20	2	Skylight Details
A21	3	Exterior Joinery Schedule
A22	4	Architectural Details
A23	1	Architectural Details
A24	1	Hoardings & Safety Barriers
A25	D	Emergency Lighting Plan
A26	1	Electrical Layout Plan

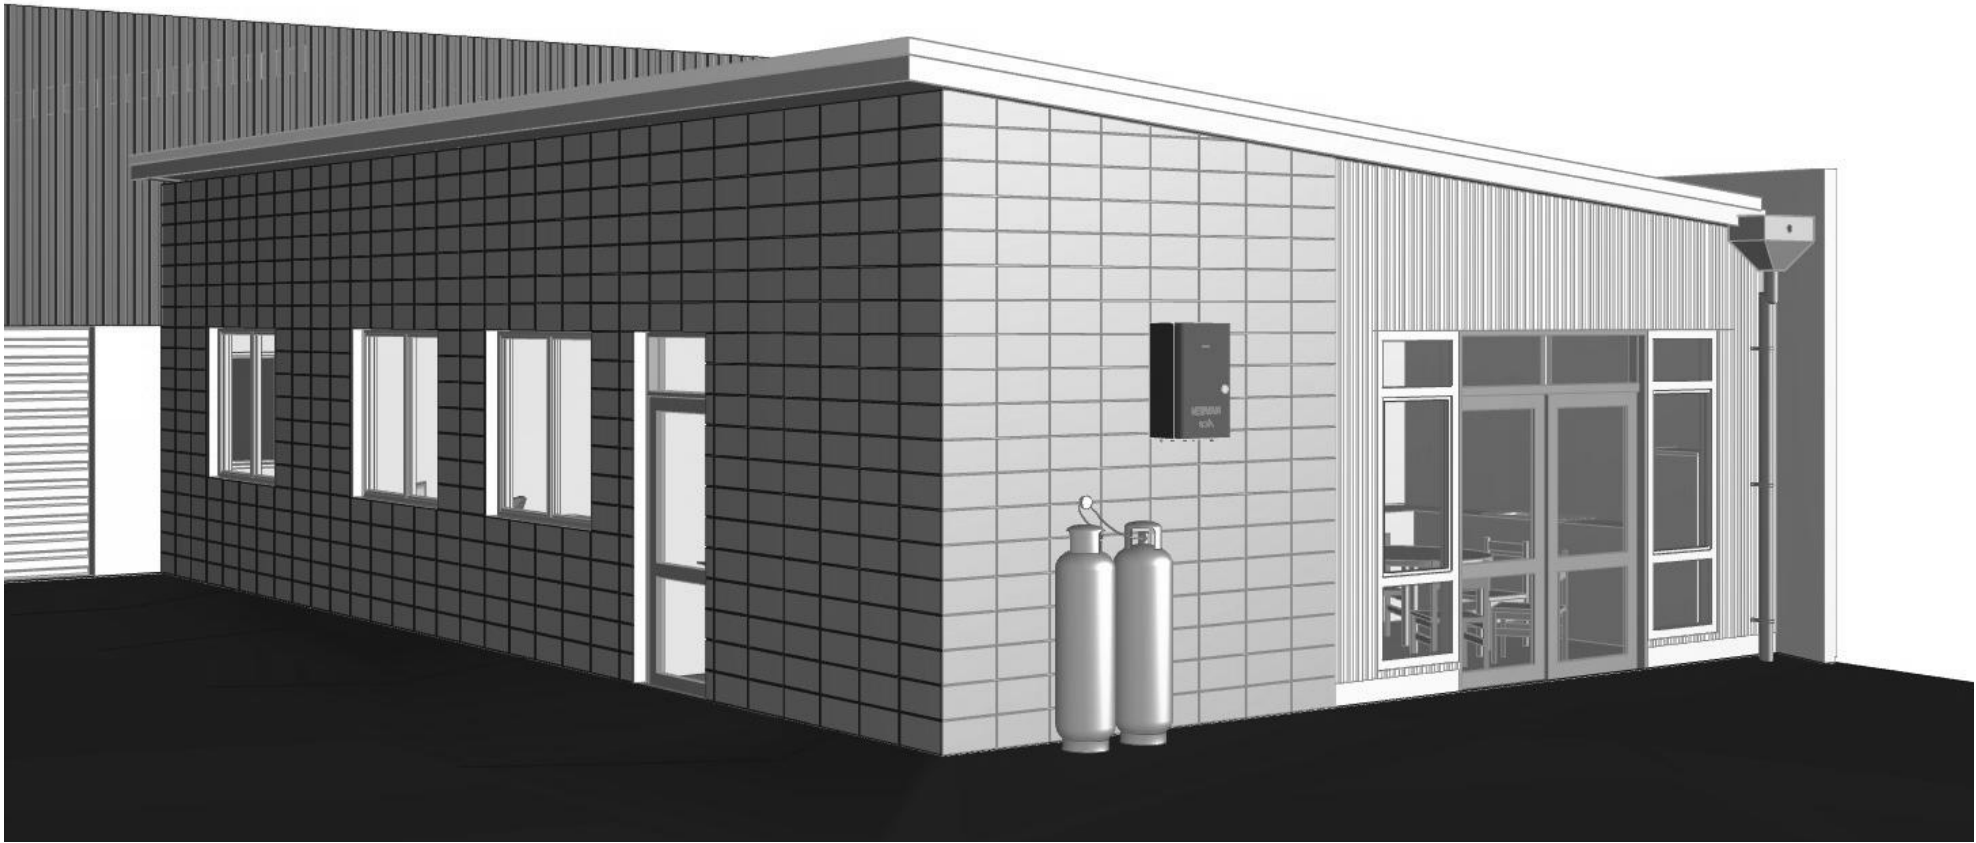

Amendment #2

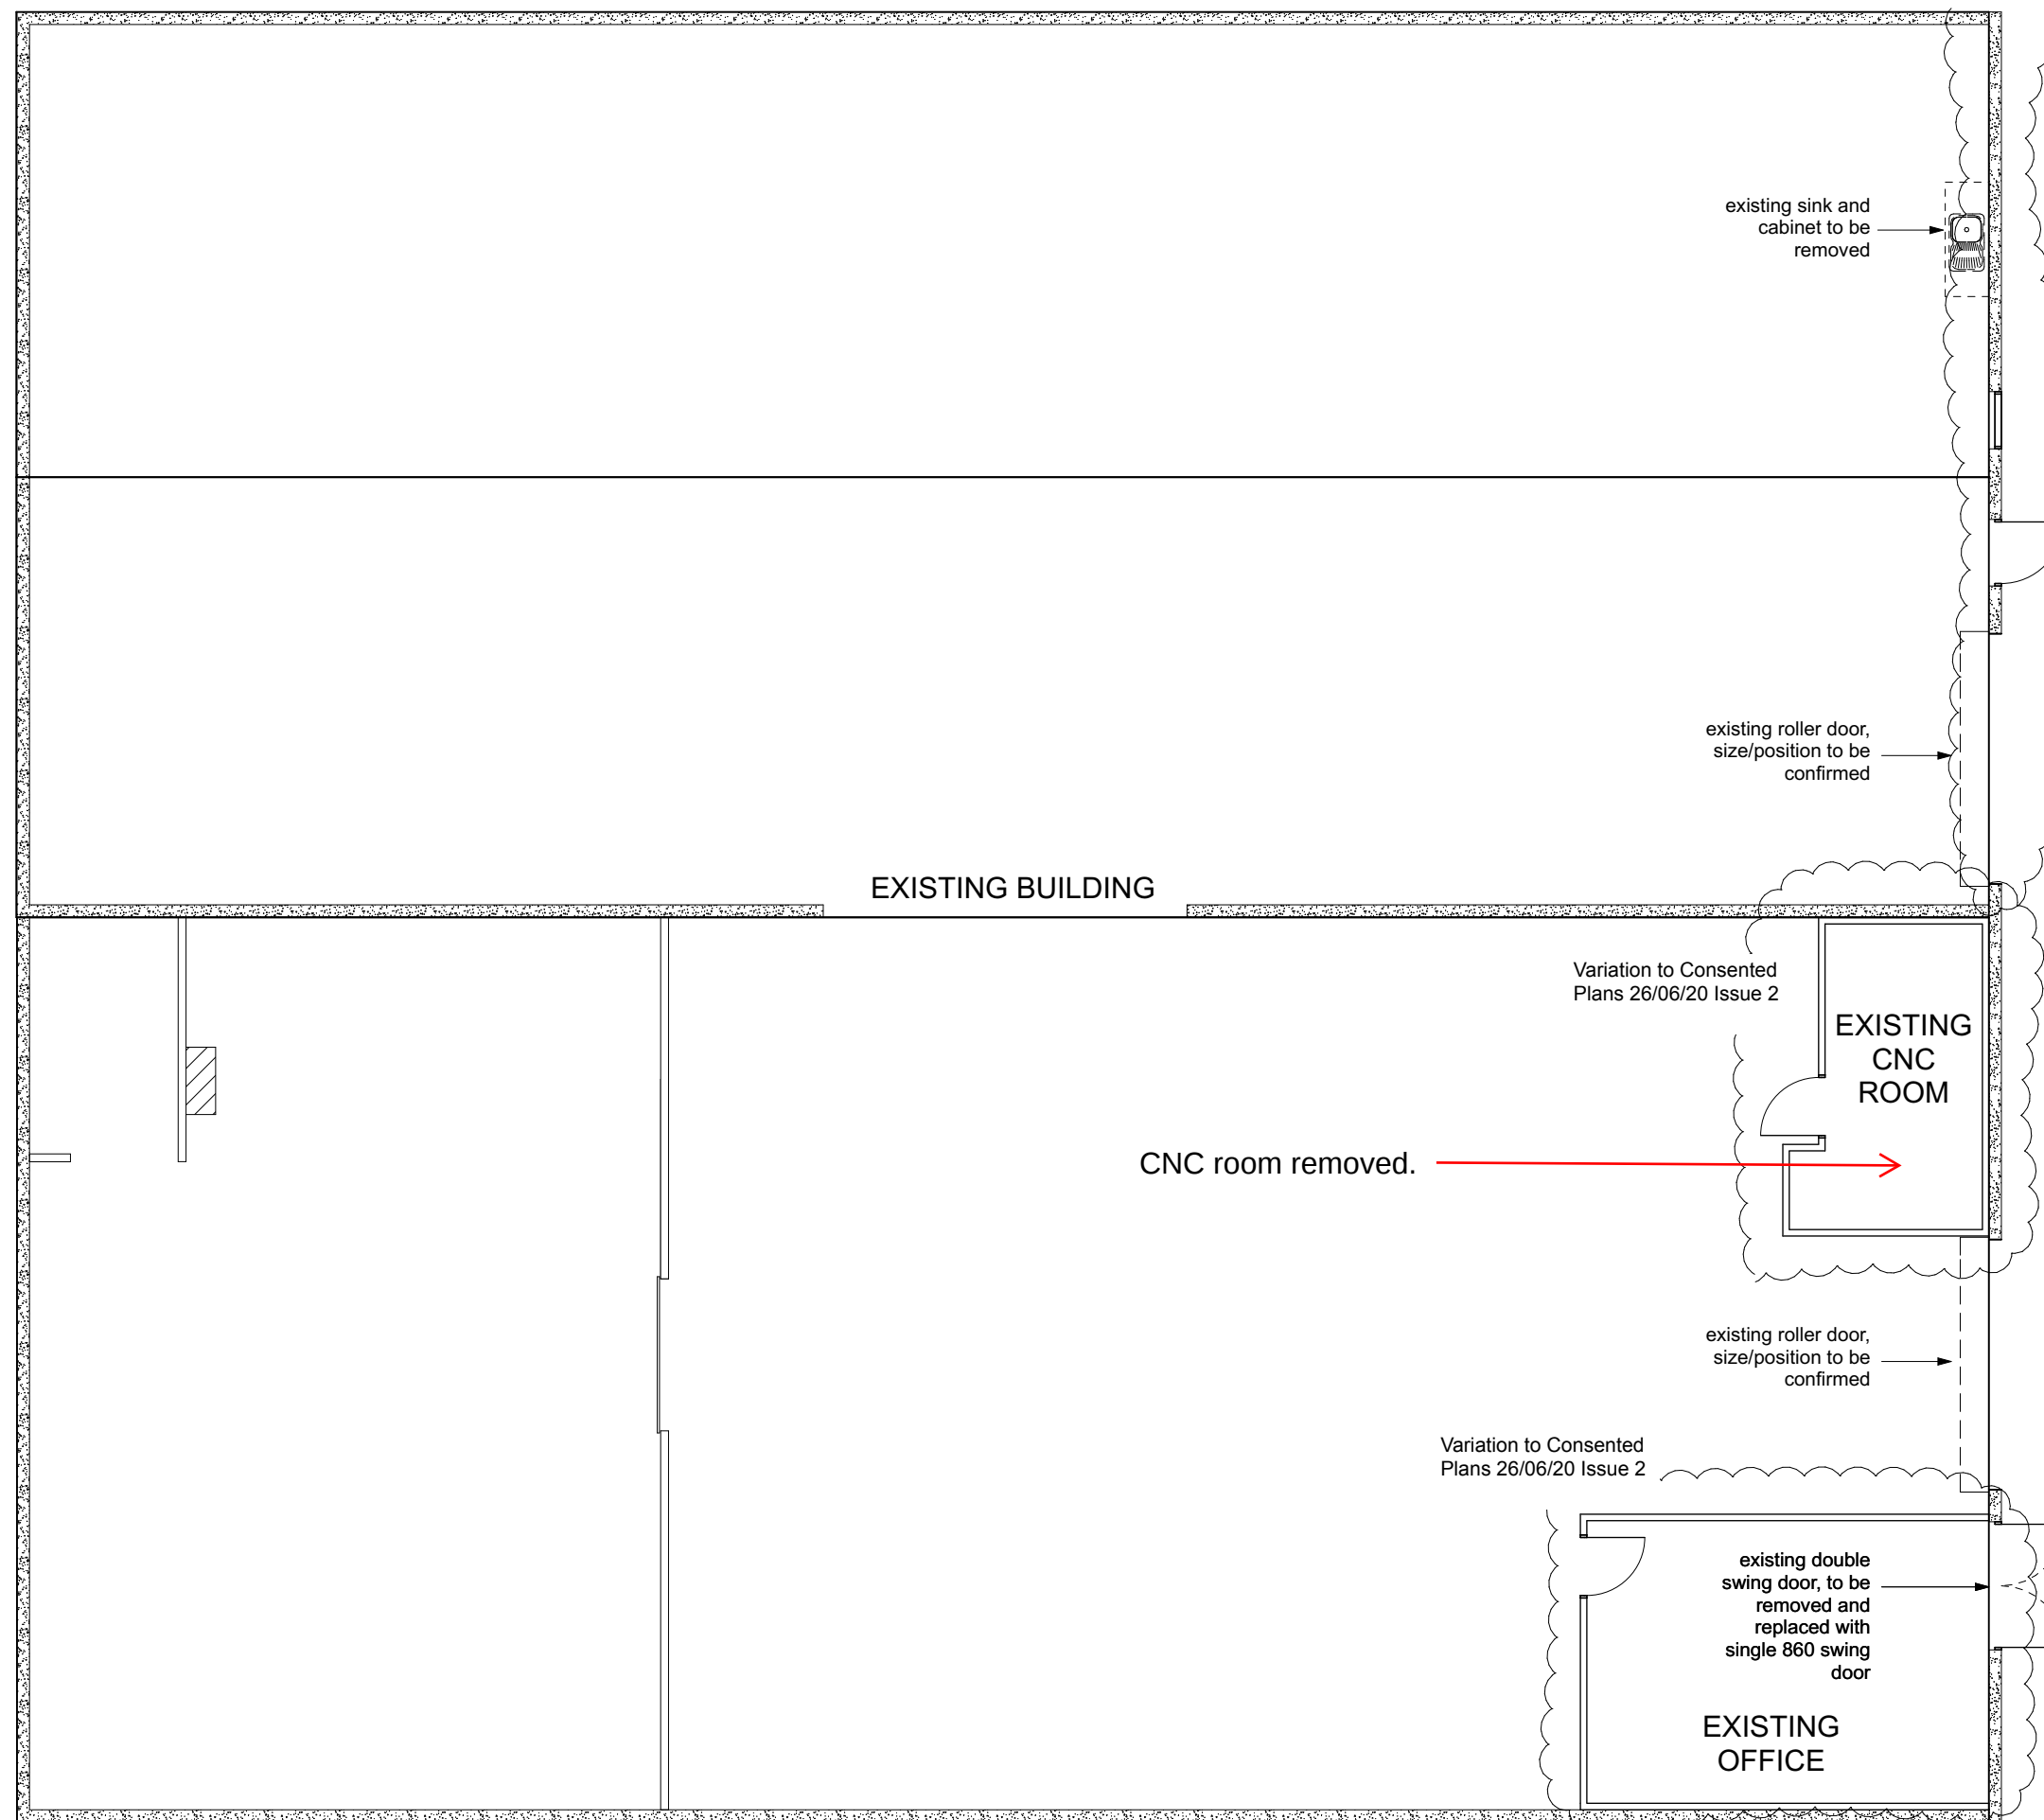

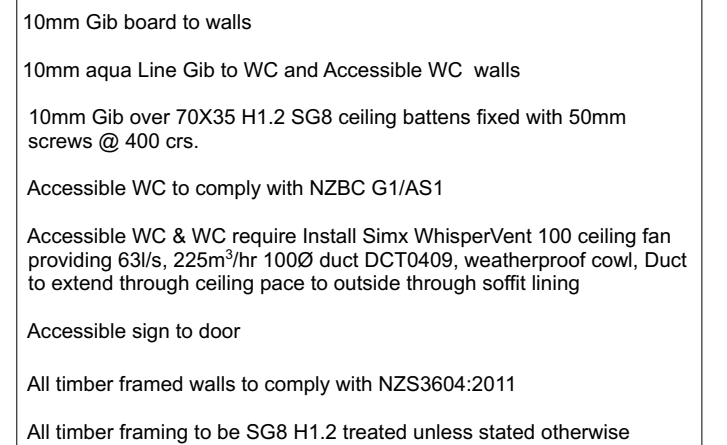

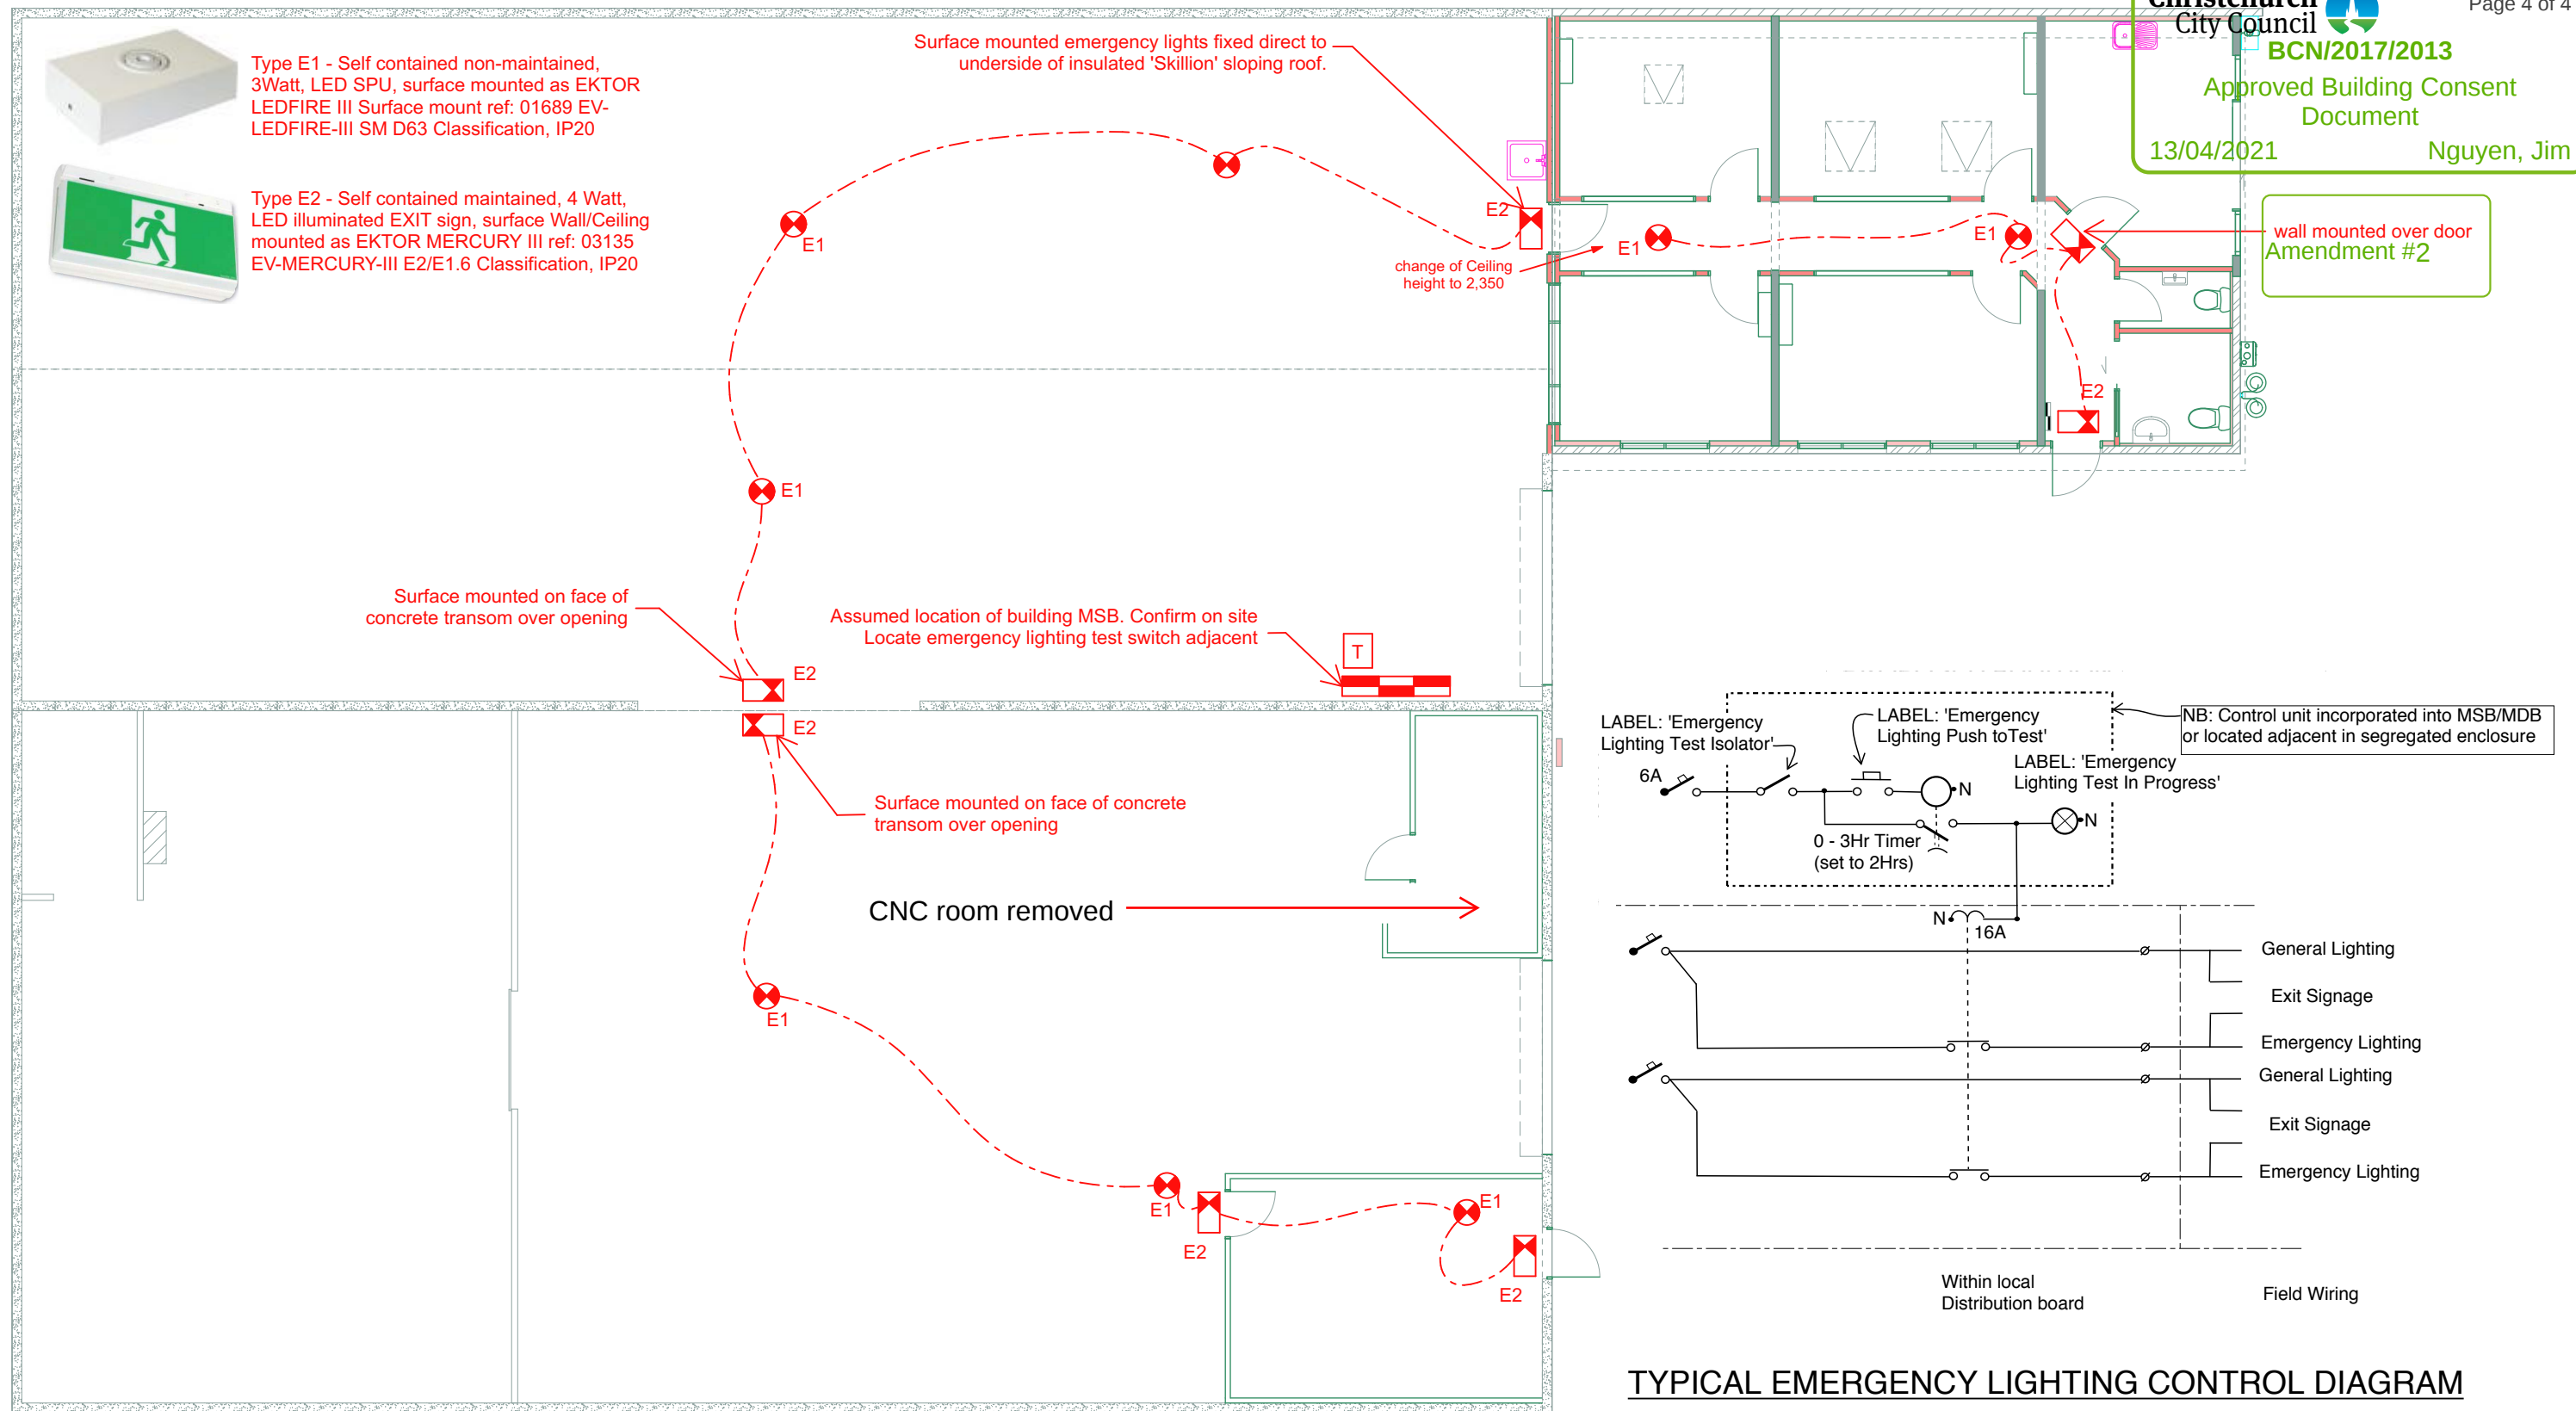

Symbol	Description
	New emergency luminaire (surface/recessed)
	New illuminated EXIT sign (Directional as required)
	Main switchboard -MSB
	Emergency lighting test point at MSB
	emergency circuiting line

NOTES:
This drawing to be read in conjunction with the separately attached 'Notes' & 'Specifications' sheets

CHECK ALL INFORMATION ON SITE PRIOR TO COMMENCING WORK. READ IN CONJUNCTION WITH THE SPECIFICATION AND OTHER RELEVANT DRAWINGS AND DOCUMENTS		
ISSUE	AMENDMENT	DATE
D	REVISED CONSENT ISSUE	02.03.20
C	REVISED CONSENT ISSUE	24.02.20
B	REVISED CONSENT ISSUE	06.11.19
A	CONSENT ISSUE	18.07.17



PROJECT
EQ STRENGTHENING & PROPOSED OFFICE,
80 BYRON STREET,
CHRISTCHURCH

SHEET TITLE:
EMERGENCY LIGHTING LAYOUT

03/03/2020 Minor Variation		
CONSENT		
DESIGNED: RLW	DATE: 18.07.17	ISSUE: D
DRAWN: RLW	SCALE: NTS	
SHEET No: CC16175-EL.01		