


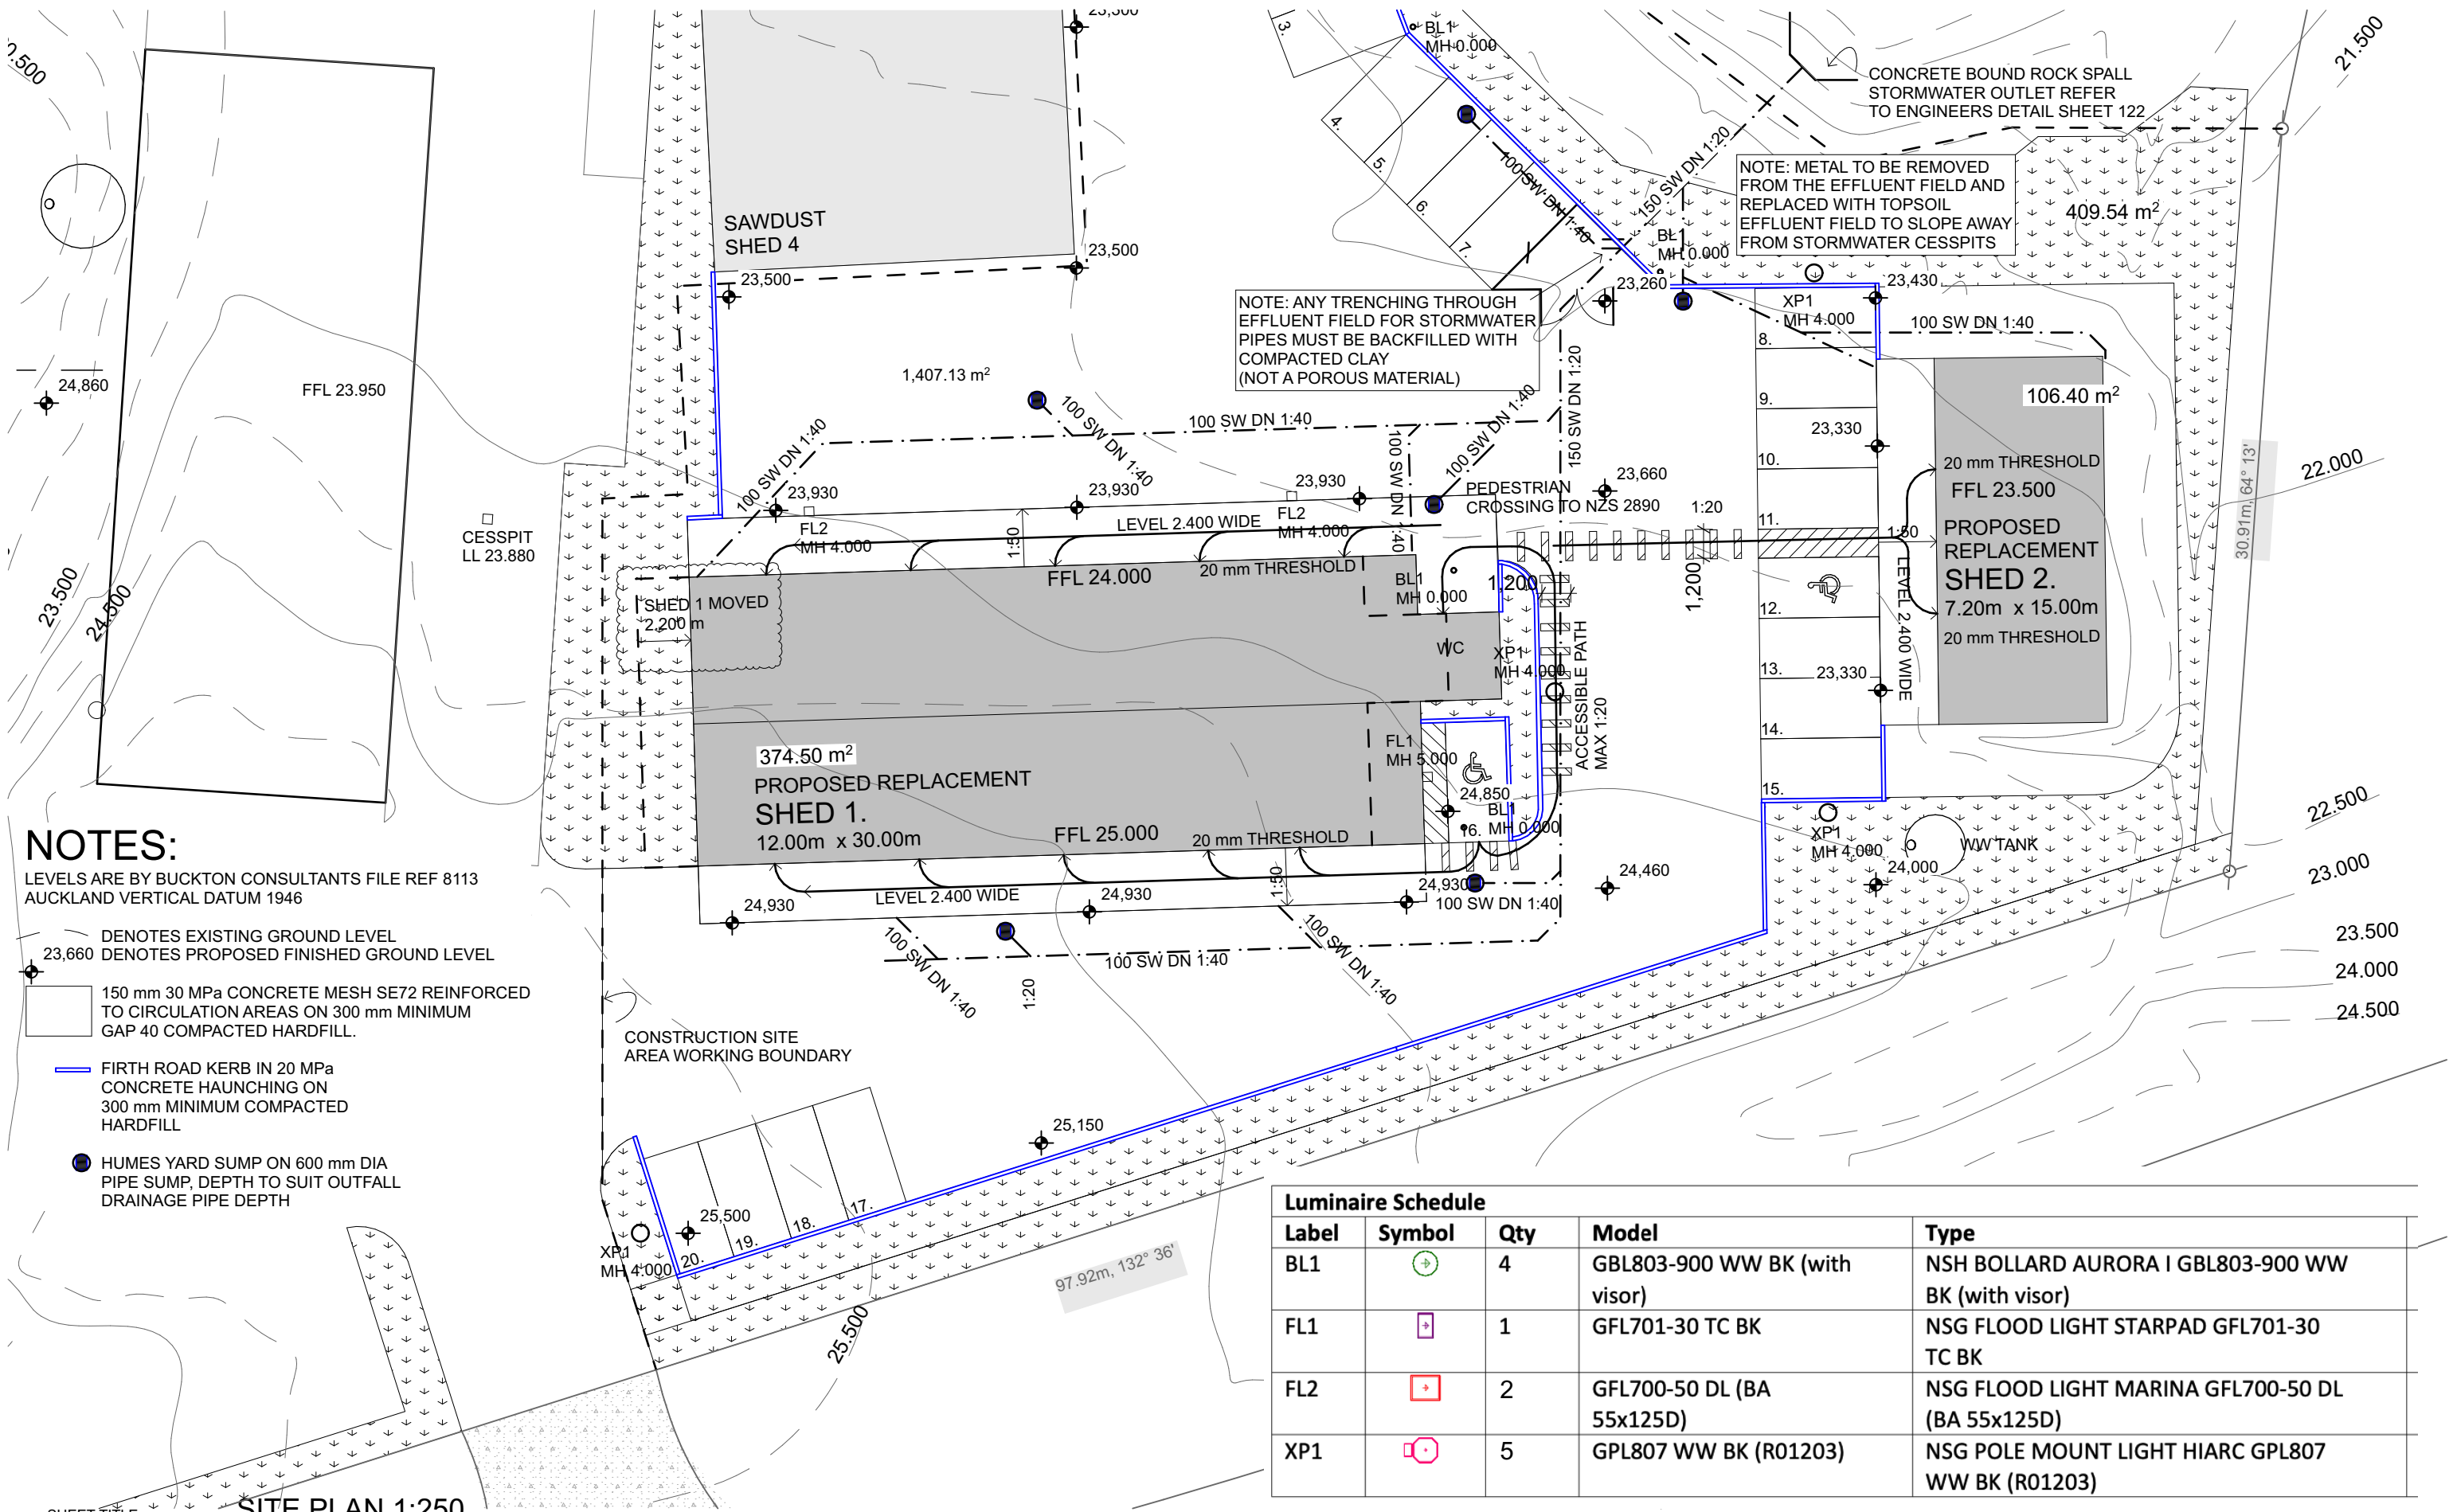

- NOTES:**
- LEVELS ARE BY BUCKTON CONSULTANTS FILE REF 8113 AUCKLAND VERTICAL DATUM 1946
 - DENOTES EXISTING GROUND LEVEL
 - 23,660 DENOTES PROPOSED FINISHED GROUND LEVEL
 - 150 mm 30 MPa CONCRETE MESH SE72 REINFORCED TO CIRCULATION AREAS ON 300 mm MINIMUM GAP 40 COMPACTED HARDFILL.
 - FIRTH ROAD KERB IN 20 MPa CONCRETE HAUNCHING ON 300 mm MINIMUM COMPACTED HARDFILL
 - HUMES YARD SUMP ON 600 mm DIA PIPE SUMP, DEPTH TO SUIT OUTFALL DRAINAGE PIPE DEPTH

Luminaire Schedule				
Label	Symbol	Qty	Model	Type
BL1		4	GBL803-900 WW BK (with visor)	NSH BOLLARD AURORA I GBL803-900 WW BK (with visor)
FL1		1	GFL701-30 TC BK	NSG FLOOD LIGHT STARPAD GFL701-30 TC BK
FL2		2	GFL700-50 DL (BA 55x125D)	NSG FLOOD LIGHT MARINA GFL700-50 DL (BA 55x125D)
XP1		5	GPL807 WW BK (R01203)	NSG POLE MOUNT LIGHT HIARC GPL807 WW BK (R01203)

SHEET TITLE

REVISION #:

SHEET

A: SKETCH DESIGN

D: BC ISSUE

G: WALL FRAMING REVISED

H: SHED 1 MOVED, RL'S REV

ISSUED: 1/05/24

H PROJECT #: 21015

THREE BLOKES LTD

REPLACEMENT MARKET SHEDS

362 MATAKANA VALLEY ROAD

MATAKANA

CAMPBELL REGISTERED ARCHITECTS Ltd

202 CAMES ROAD, R.D. 5 WELLSFORD 0975 NEW ZEALAND

~ p: 0274 323 185

~ e: colin@campbell-registered-architects.co.nz

~ w: www.campbell-registered-architects.co.nz

BCO10364430-A Received by Auckland Council 08/05/2024