


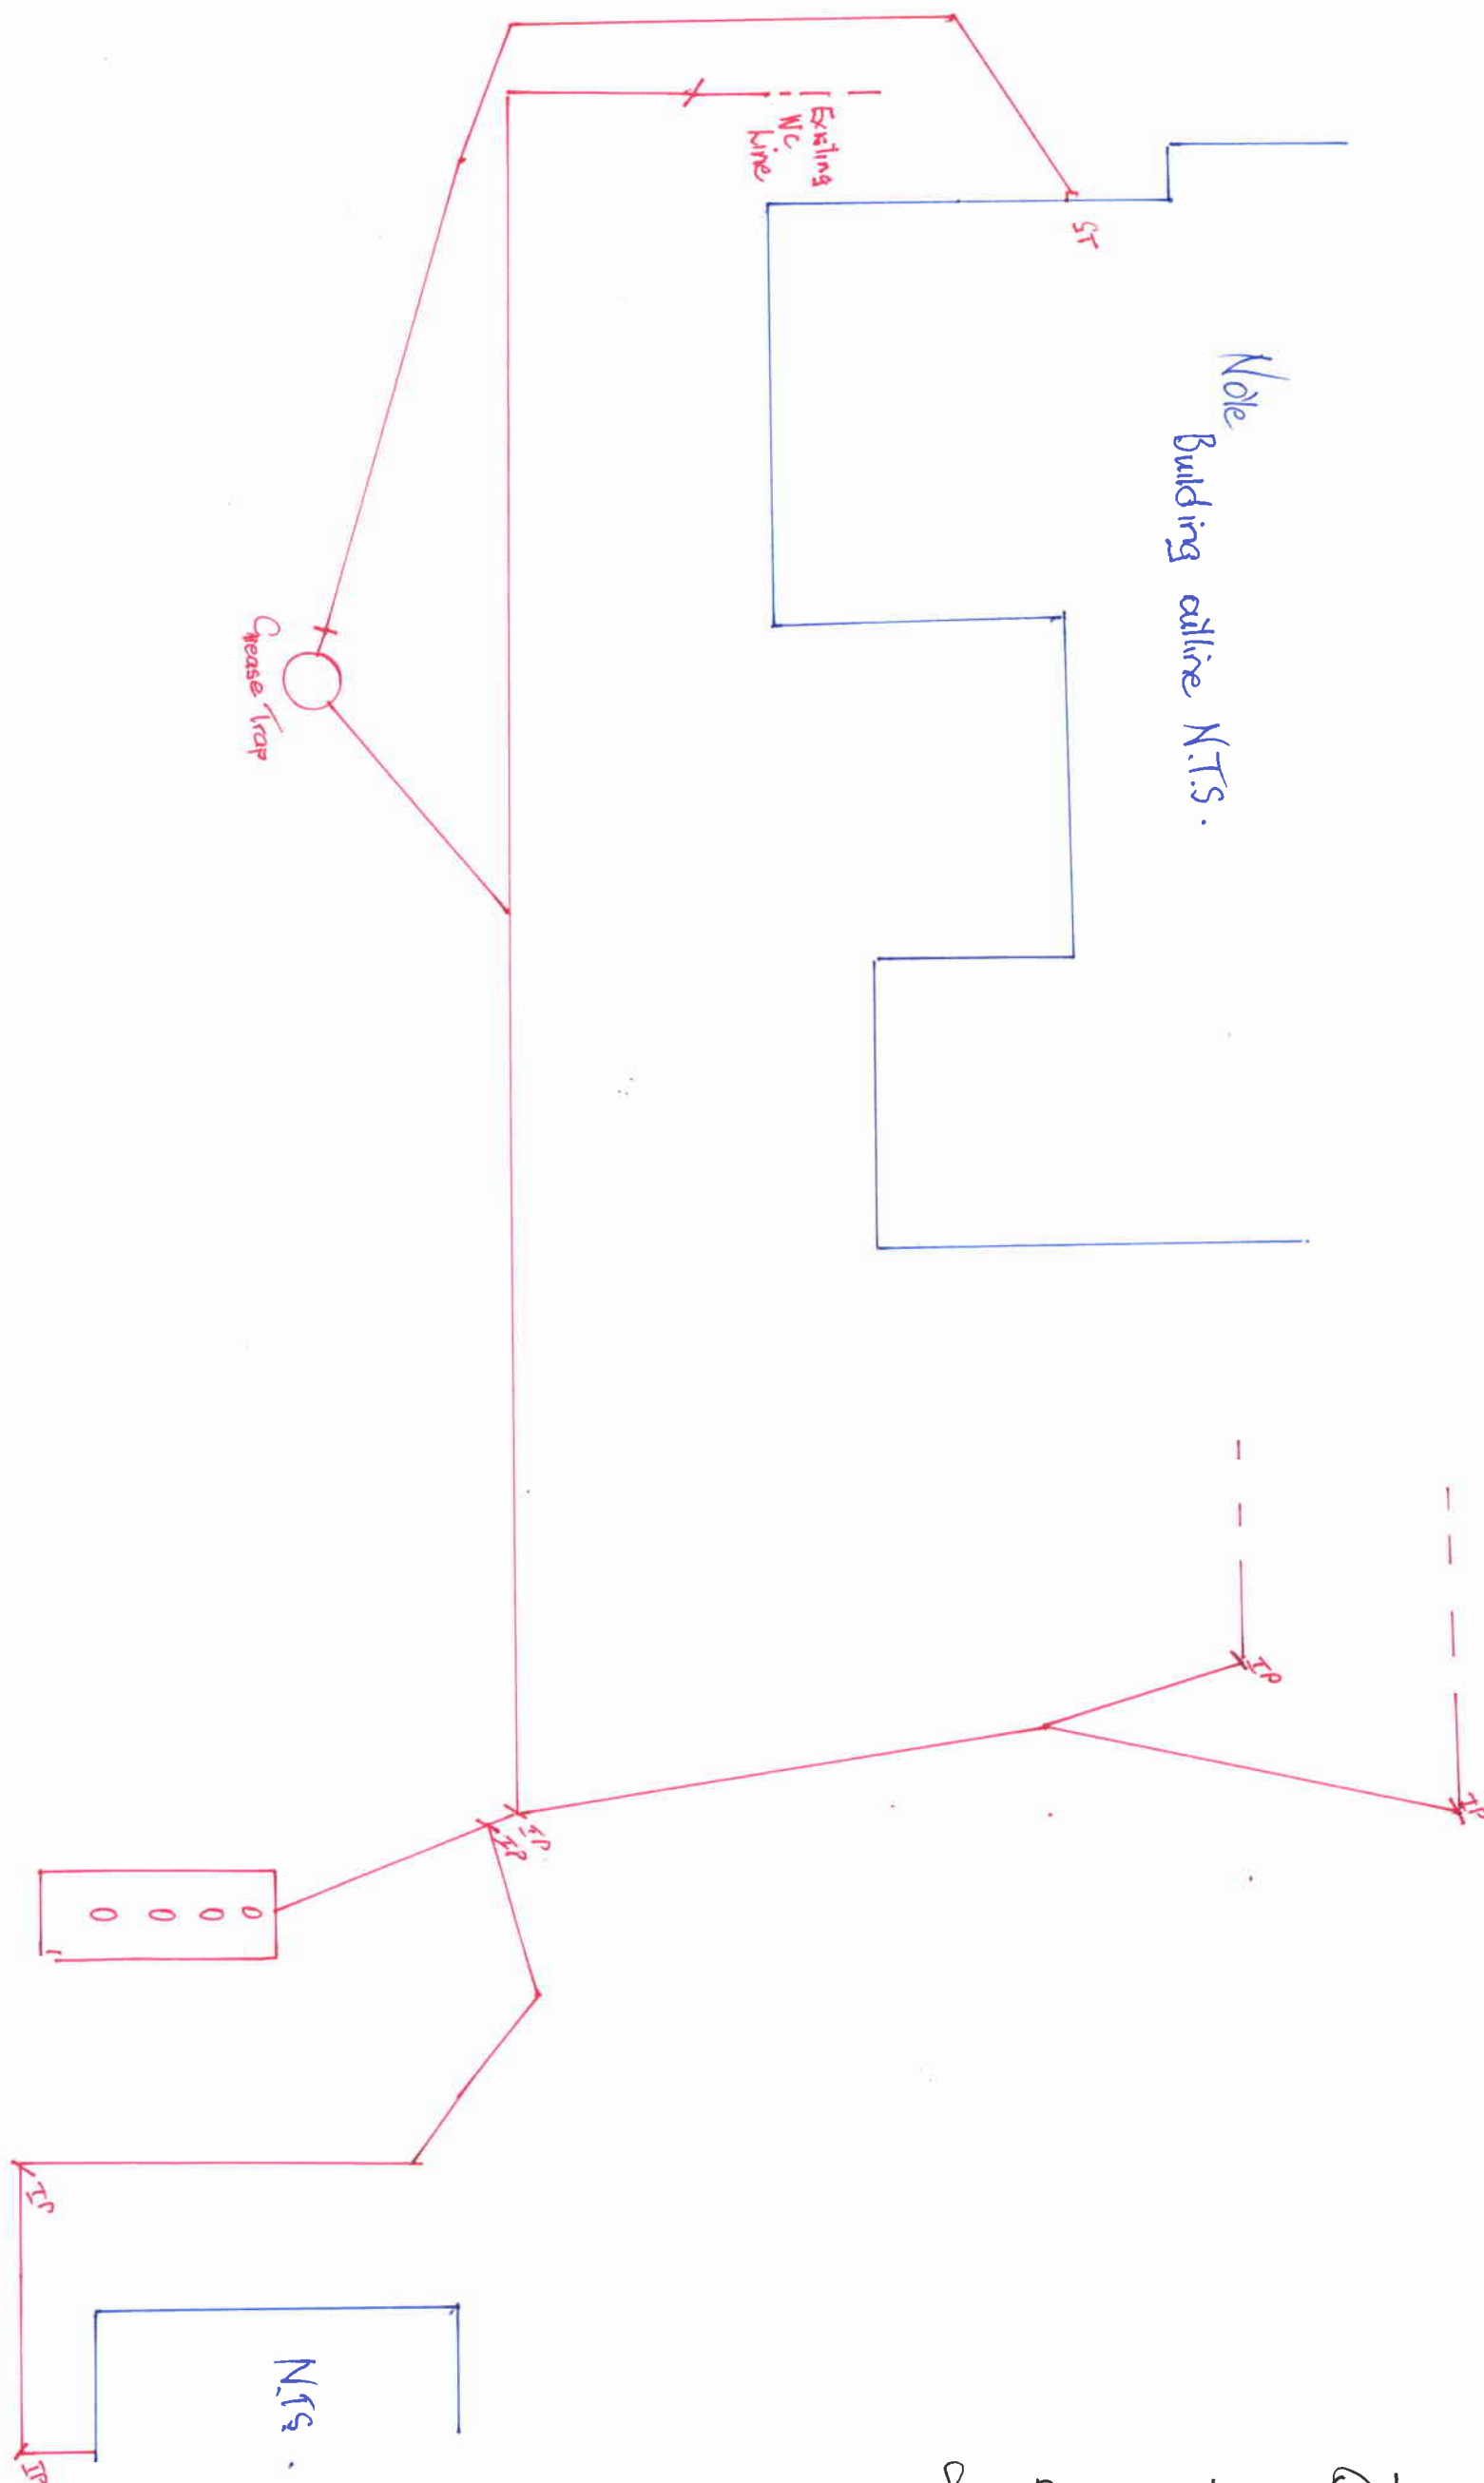

Scale for Drainage Lines Only

LEGEND		DRAINAGE PLAN	
SEWER	—	STORMWATER	—
NAME:	S & M. Coffey & Longstaff Trustee	JOB N°	111440
ADDRESS:	24 Canterbury Street Ashley	VAL N°	2144002300
DRAINLAYER:	Hansen	INSPECTED:	LB
		DATE DRAWN:	2. 9. 14